

1. THIS DRAWING IS PART OF THE SET OF PLANNING DRAWINGS LISTED BELOW AND IS TO BE READ IN CONJUNCTION WITH THESE DRAWINGS AND ALL OTHER DOCUMENTATION ASSOCIATED WITH THE HORIZON PLANNING SUBMISSION FOR THE ALTERNATIVE PREMISES FOR THE MAGNOX AECC AND DSL.

Planning Drawing Reference	Planning Drawing Title
WN-HOR-MAP-PLN-10001	Magnox AECC and DSL Site Location Plan
WN-HOR-MAP-PLN-10002	Magnox AECC and DSL Site Plan
WN-HOR-MAP-PLN-10003	Magnox AECC and DSL External Works General Arrangement
WN-HOR-MAP-PLN-10004	Magnox AECC and DSL Ground Floor and Roof Plan
WN-HOR-MAP-PLN-10005	Magnox AECC and DSL North, East, South and West Building Elevations
WN-HOR-MAP-PLN-10008	Magnox AECC and DSL Earthworks Cut and Fill Balance
WN-HOR-MAP-PLN-10009	Magnox AECC and DSL External Works Elevations 'A-B' and 'C-D'
WN-HOR-MAP-PLN-10010	Magnox AECC and DSL Landscape and Ecological Enhancement Plan
WN-HOR-MAP-PLN-10012	Magnox AECC and DSL External Lighting Plan
WN-HOR-MAP-PLN-10013	Magnox AECC and DSL External Works Elevation 'E-F'
WN-HOR-MAP-PLN-10014	Magnox AECC and DSL External Works Fencing Detail
WN-HOR-MAP-PLN-10015	Magnox AECC and DSL Highway Works Plan
WN-HOR-MAP-PLN-10017	Magnox AECC and DSL planting Plan

2. DO NOT SCALE FROM THIS DRAWING, USE ONLY PRINTED DIMENSIONS.

3. ALL DIMENSIONS IN MILLIMETRES, ALL CHAINAGES, LEVELS, AND COORDINATES ARE IN METRES UNLESS DEFINED OTHERWISE.

4. THIS DRAWING IS TO BE READ IN CONJUNCTION WITH THE PROJECT HEALTH AND SAFETY FILE FOR ANY IDENTIFIED POTENTIAL RISKS.

5. ROOF TO HAVE A MINIMUM FINISHED FALL WHICH MEETS THE REQUIREMENTS OF BS 6229:2003

GROSS INTERNAL AREA

AECC / DSL	179m ²
SAMPLE PREPARATION ROOM	15m ²
TOTAL	194m²

High level windows indicated as requested by planning	CS	HS	03.05.16	PL9
Update in line with IC review	CS	HS	19.04.16	PL8
Update in line with IC review	CS	HS	13.04.16	PL7
Update in line with IC review	CS	HS	07.04.16	PL6
Update to drawing in accordance with client comments	CS	HS	09.03.16	PL5
Update to drawing title block and materials legend in accordance with client comments	RG	HS	26.01.16	PL4
Revision Details	By	Check	Date	Rev

Purpose of Issue **PLANNING**

Project Title
MAGNOX ALTERNATIVE PREMISES - AECC AND DSL

Drawing Title
MAGNOX AECC AND DSL GROUND FLOOR AND ROOF PLAN

Designed	Drawn	Checked	Approved	Date
HS	VT	HS	GP	09-03-2016


Scale @ A1	Zone / Message
	Subsidiary BS 1192

HORIZON NUCLEAR POWER WYLFA LIMITED

Sunrise House
1420 Charlton Court
Gloucester Business Park
Gloucester
GL3 4AE

PWR NIWCLAR
HORIZON
NUCLEAR POWER



Drawing Number	Rev
WN-HOR-MAP-PLN-10004	PL9

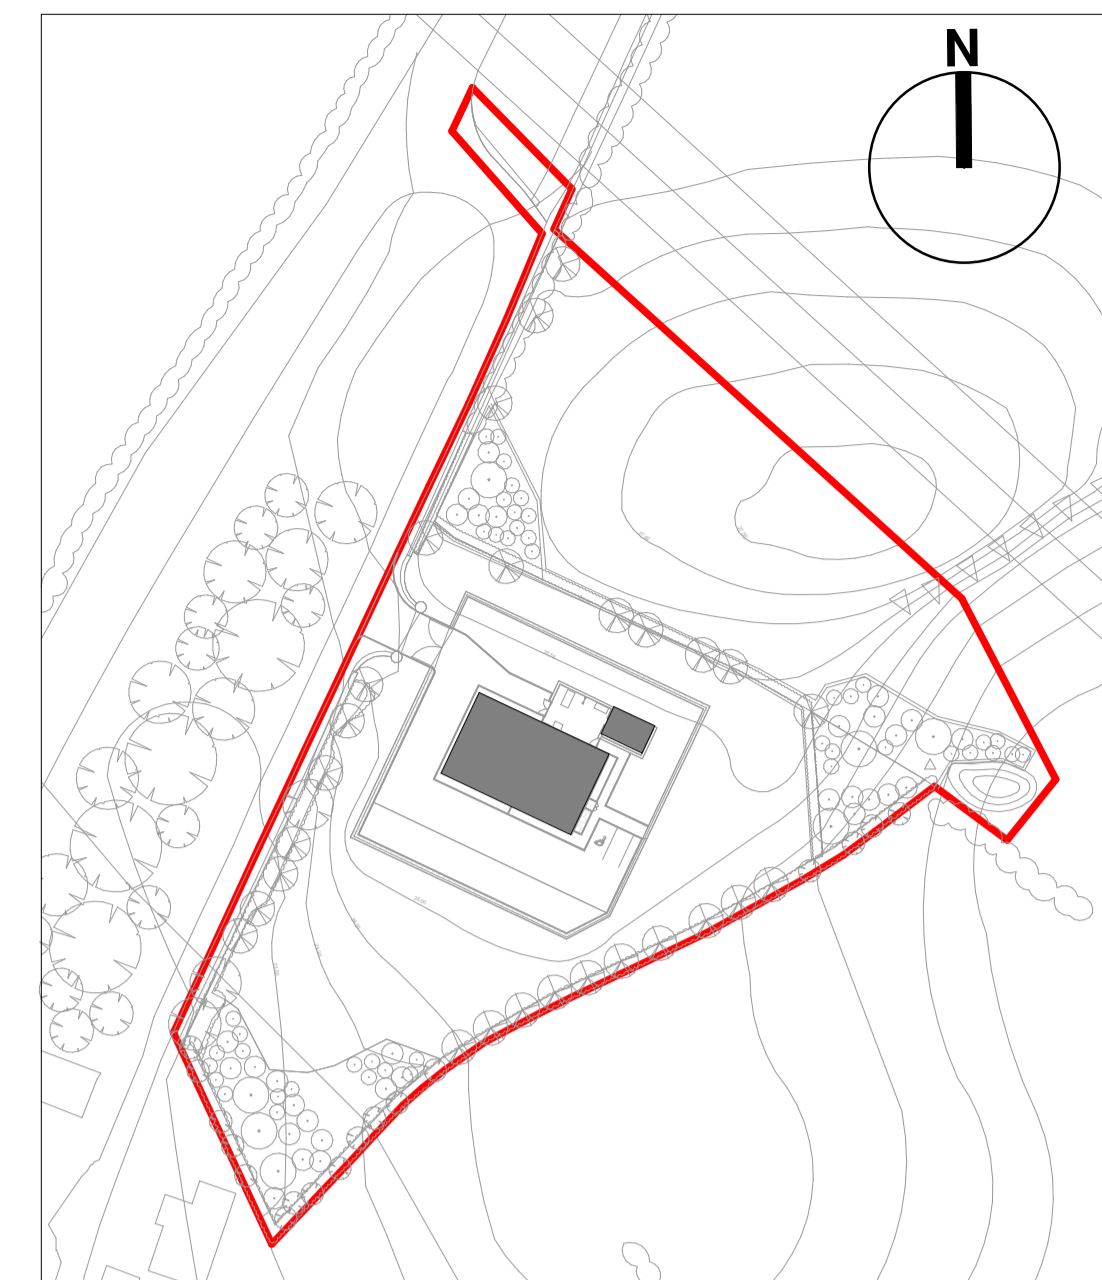

KEY PLAN


EXTERNAL ELEMENTS PLAN REF:

1. Refuse Containers
2. Sheffield Cycle Stand
3. Emergency Power Generator
4. Variable Refrigeration Flow Condensers for Heating and Cooling Systems
5. Nitrogen Vessel Storage Cage

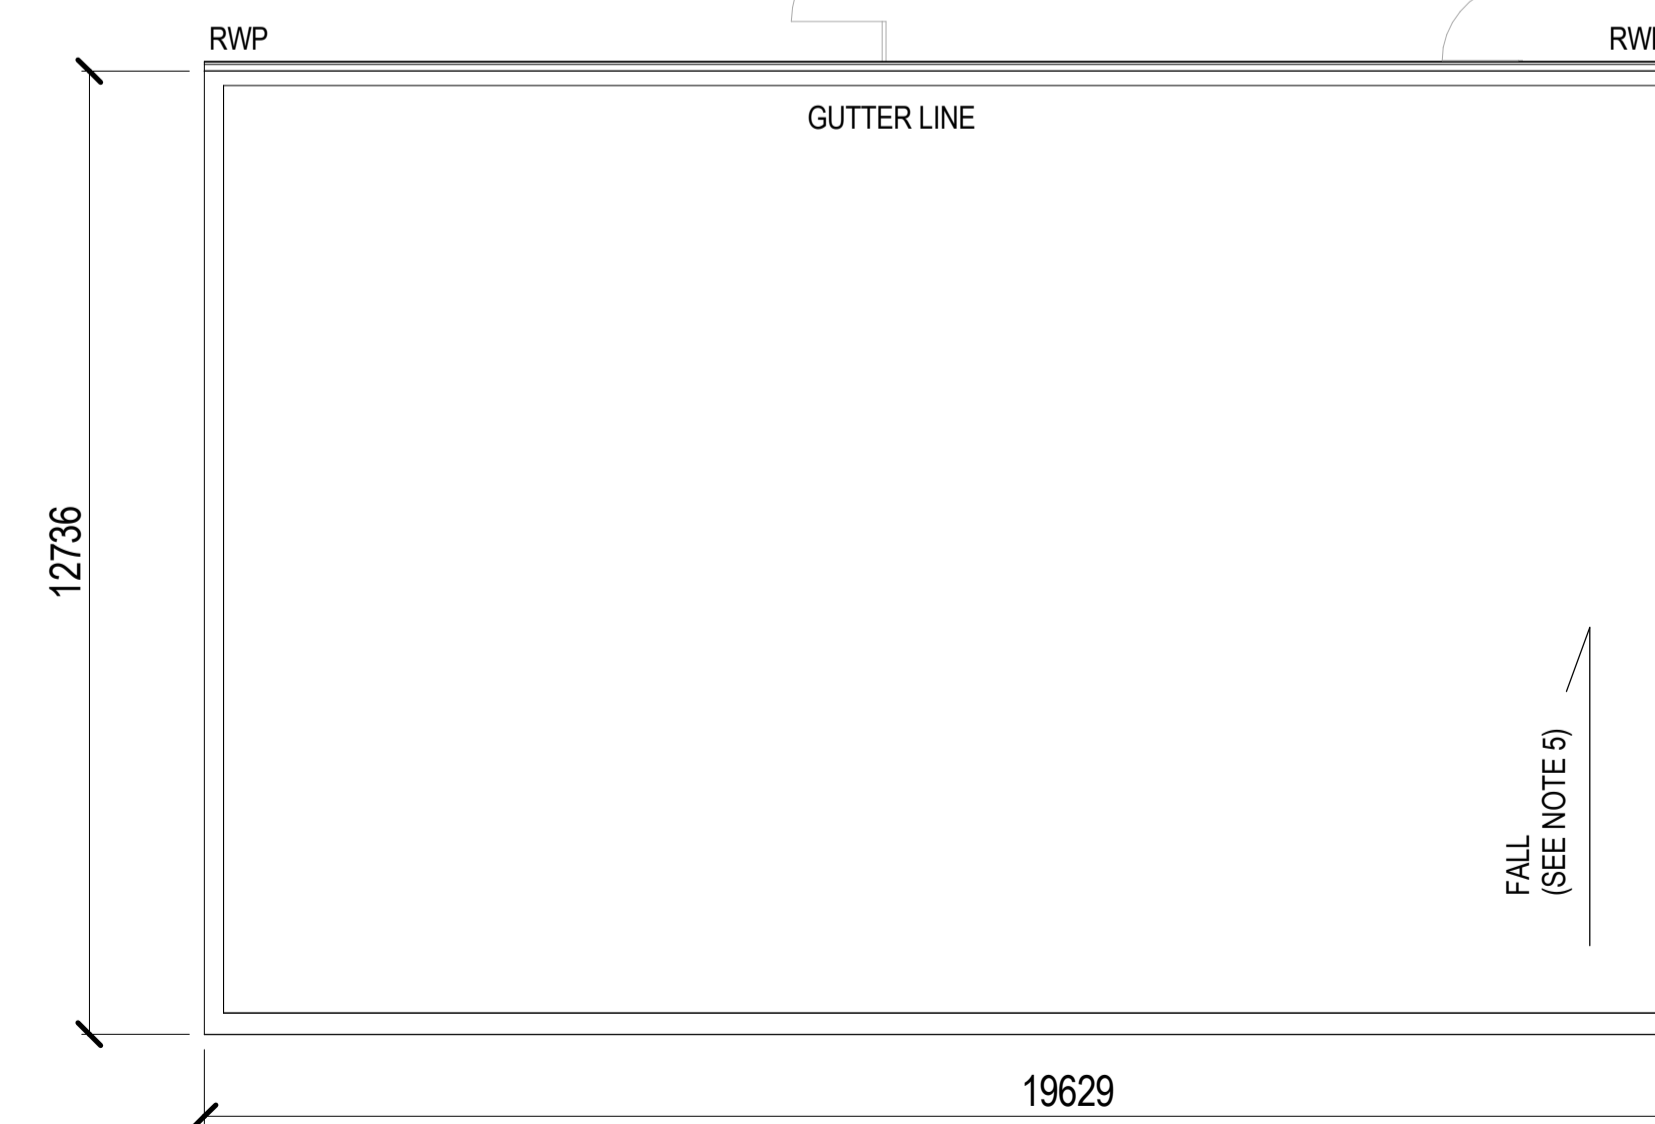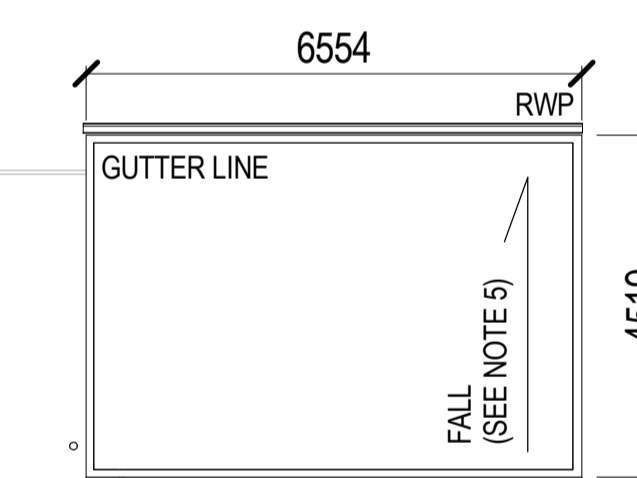


ROOF PLAN

SCALE: 1 : 100

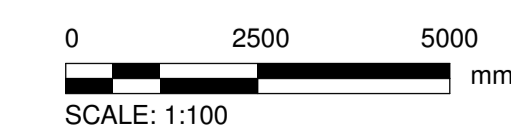

NOT PROTECTIVELY MARKED

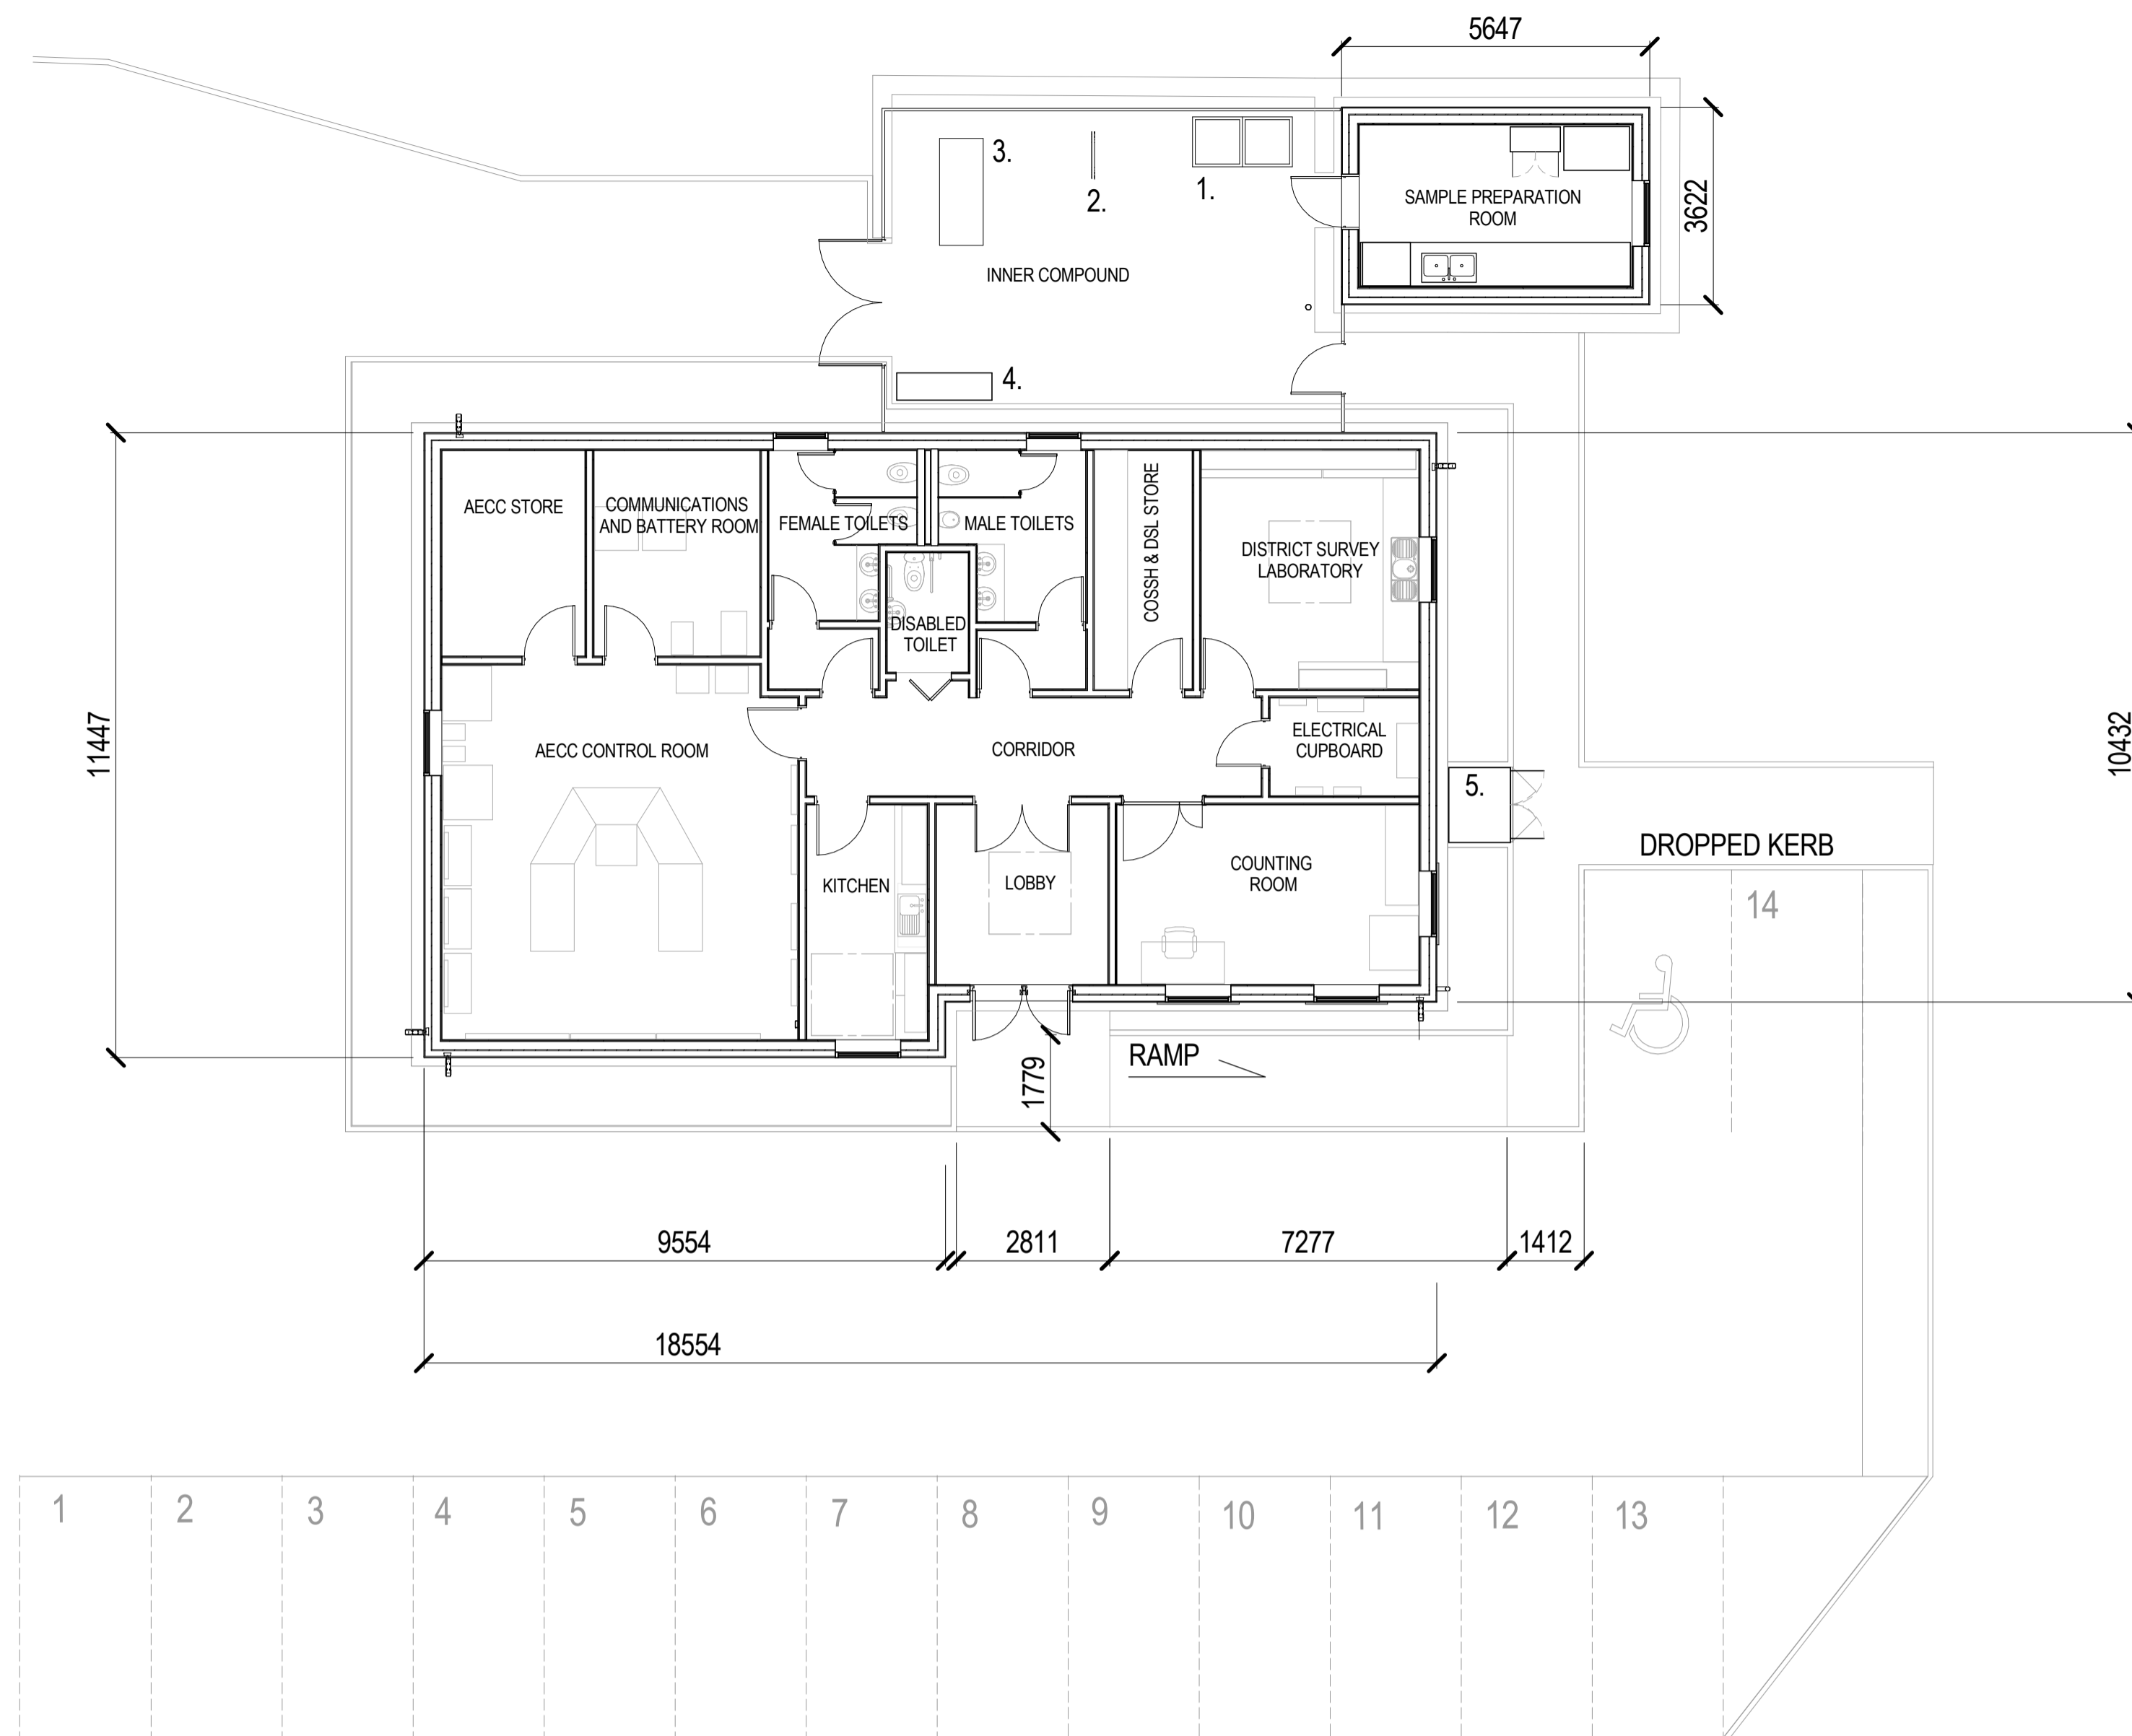

GROUND FLOOR PLAN

SCALE: 1 : 100