

A5025
(Main Road)

Existing trees

Existing road

Hedgerow to be gapped up and native feathered trees added

Graded bank with wildflower meadow

3 m High Secure Guard 358 Rigid Mesh fencing with stone chip trim


Vehicular tarmacadam

3 m High Secure Guard 358 Rigid Mesh fencing with stone chip trim

Wildflower meadow

Hedgerow to be gapped up and native feathered trees added

A-B West to East elevation
1:100

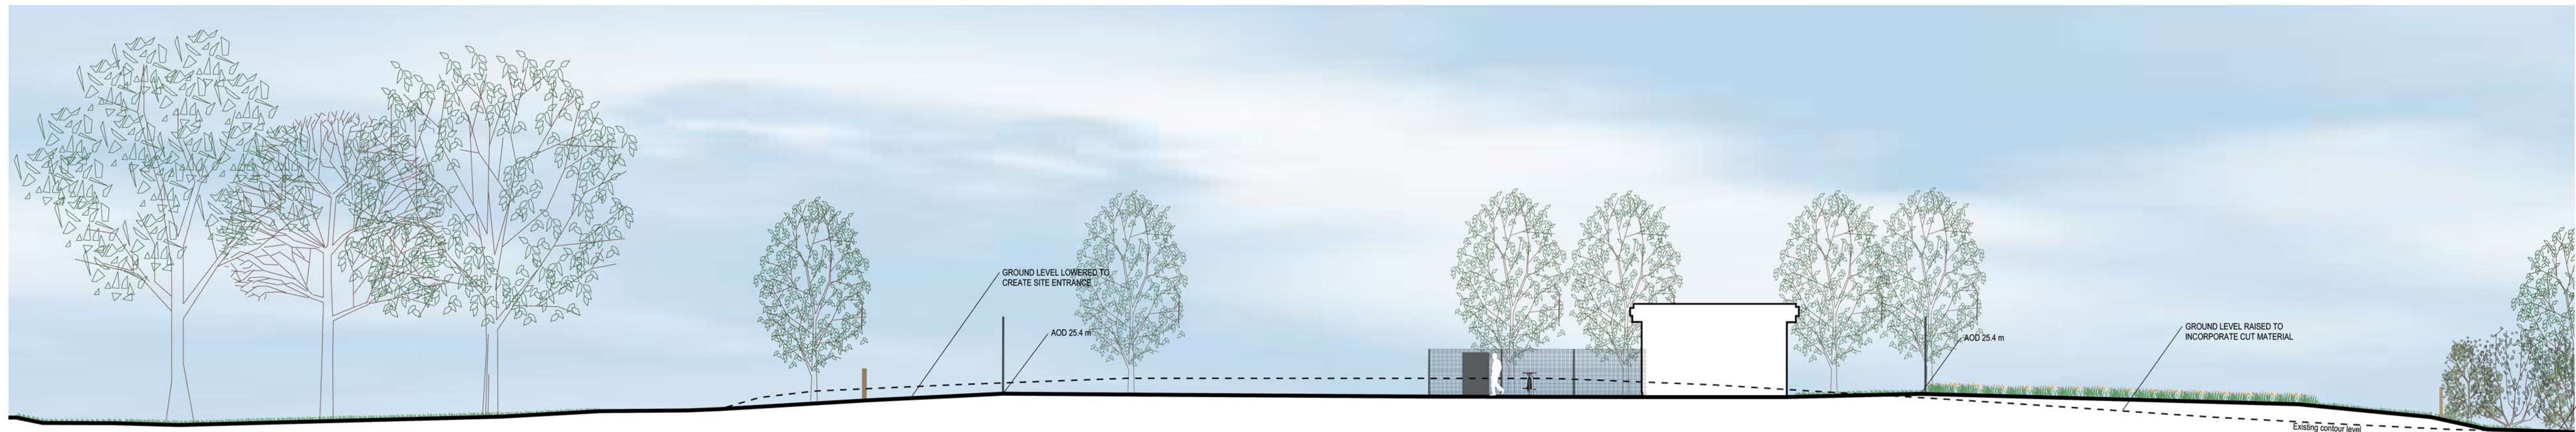

A5025
(Main Road)

Existing trees

Existing road

1.2m High Wooden Field Gate

3 m High Secure Guard 358 Rigid Mesh fencing with stone chip trim

1.8 m High Pro-Guard Rigid Mesh Fencing with stone chip trim
Generator Sheffield Bicycle Stand

Concrete Sample preparation room

3 m High Secure Guard 358 Rigid Mesh fencing with stone chip trim

Graded bank with wildflower meadow

Proposed hedgerow with temporary 1.2m Rylock mesh fence
Native woodland with tree mix and native feathered trees added
Hedgerow to be gapped up and native feathered trees added

C-D West to East elevation
1:100



Section elevation location plan
1:500 @ A0

1. This drawing is part of the set of planning drawings listed below in the table and is to be read in conjunction with these drawings and all other documentation associated with the Horizon planning submission for the alternative premises for the Magnox AECC and DSL.

Planning Drawing Reference	Planning Drawing Title
WN-HOR-MAP-PLN-10001	Magnox AECC and DSL Site Location Plan
WN-HOR-MAP-PLN-10002	Magnox AECC and DSL Site Plan
WN-HOR-MAP-PLN-10003	Magnox AECC and DSL External Works General Arrangement
WN-HOR-MAP-PLN-10004	Magnox AECC and DSL Ground Floor and Roof Plan
WN-HOR-MAP-PLN-10005	Magnox AECC and DSL North, East, South and West Building Elevations
WN-HOR-MAP-PLN-10008	Magnox AECC and DSL Earthworks Cut and Fill Balance
WN-HOR-MAP-PLN-10009	Magnox AECC and DSL External Works Elevations 'A-B' and 'C-D'
WN-HOR-MAP-PLN-10010	Magnox AECC and DSL Landscape and Ecological Enhancement Plan
WN-HOR-MAP-PLN-10012	Magnox AECC and DSL External Lighting Plan
WN-HOR-MAP-PLN-10013	Magnox AECC and DSL External Works Elevation 'E-F'
WN-HOR-MAP-PLN-10014	Magnox AECC and DSL External Works Fencing Details
WN-HOR-MAP-PLN-10015	Magnox AECC and DSL Highway Works Plan
WN-HOR-MAP-PLN-10017	Magnox AECC and DSL Planting Plan

2. Do not scale from this drawing use only printed dimensions

3. All dimensions in millimeters all changes in levels and coordinates are in metres unless defined otherwise

4. This drawing is to be read in conjunction with the project health and safety file for any identified potential risks

5. All new planting shown at 15 year growth

THIS DRAWING IS TO BE USED ONLY FOR THE PURPOSE FOR WHICH IT WAS ISSUED

Purpose of Issue
PLANNING

Project Title
MAGNOX ALTERNATIVE PREMISES - AECC AND DSL

Drawing Title
EXTERNAL WORKS ELEVATIONS 'A-B' AND 'C-D'

Updated text	PHM / SF	19.04.16	PL9
Updated in Response to Comment from Consistency and Coherence Review.	CN / SF	14.04.16	PL8
Updated Section and Notes	PHM / SF	07.04.16	PL7
Updated Section	PHM / SF	08.03.16	PL6
Updated Section	PHM / SF	25.11.15	PL5
Updated Section	PHM / SF	06.11.15	PL4
Updated Section	PHM / SF	20.03.15	PL3
Updated Section	PHM / SF	09.03.15	PL2
FIRST ISSUE	PHM / SF	26.2.15	PL1

Scale 1:100 @ A0
Zone / Mileage

HORIZON NUCLEAR POWER WYLFA LIMITED

Sunrise House
1420 Charlton Court
Gloucester Business Park
Gloucester
GL3 4AE

PWR NIWCLER HORIZON NUCLEAR POWER

NOT PROTECTIVELY MARKED

Drawing Number
WN-HOR-MAP-PLN-10009

Rev
PL9